


NOT FOR CONSTRUCTION

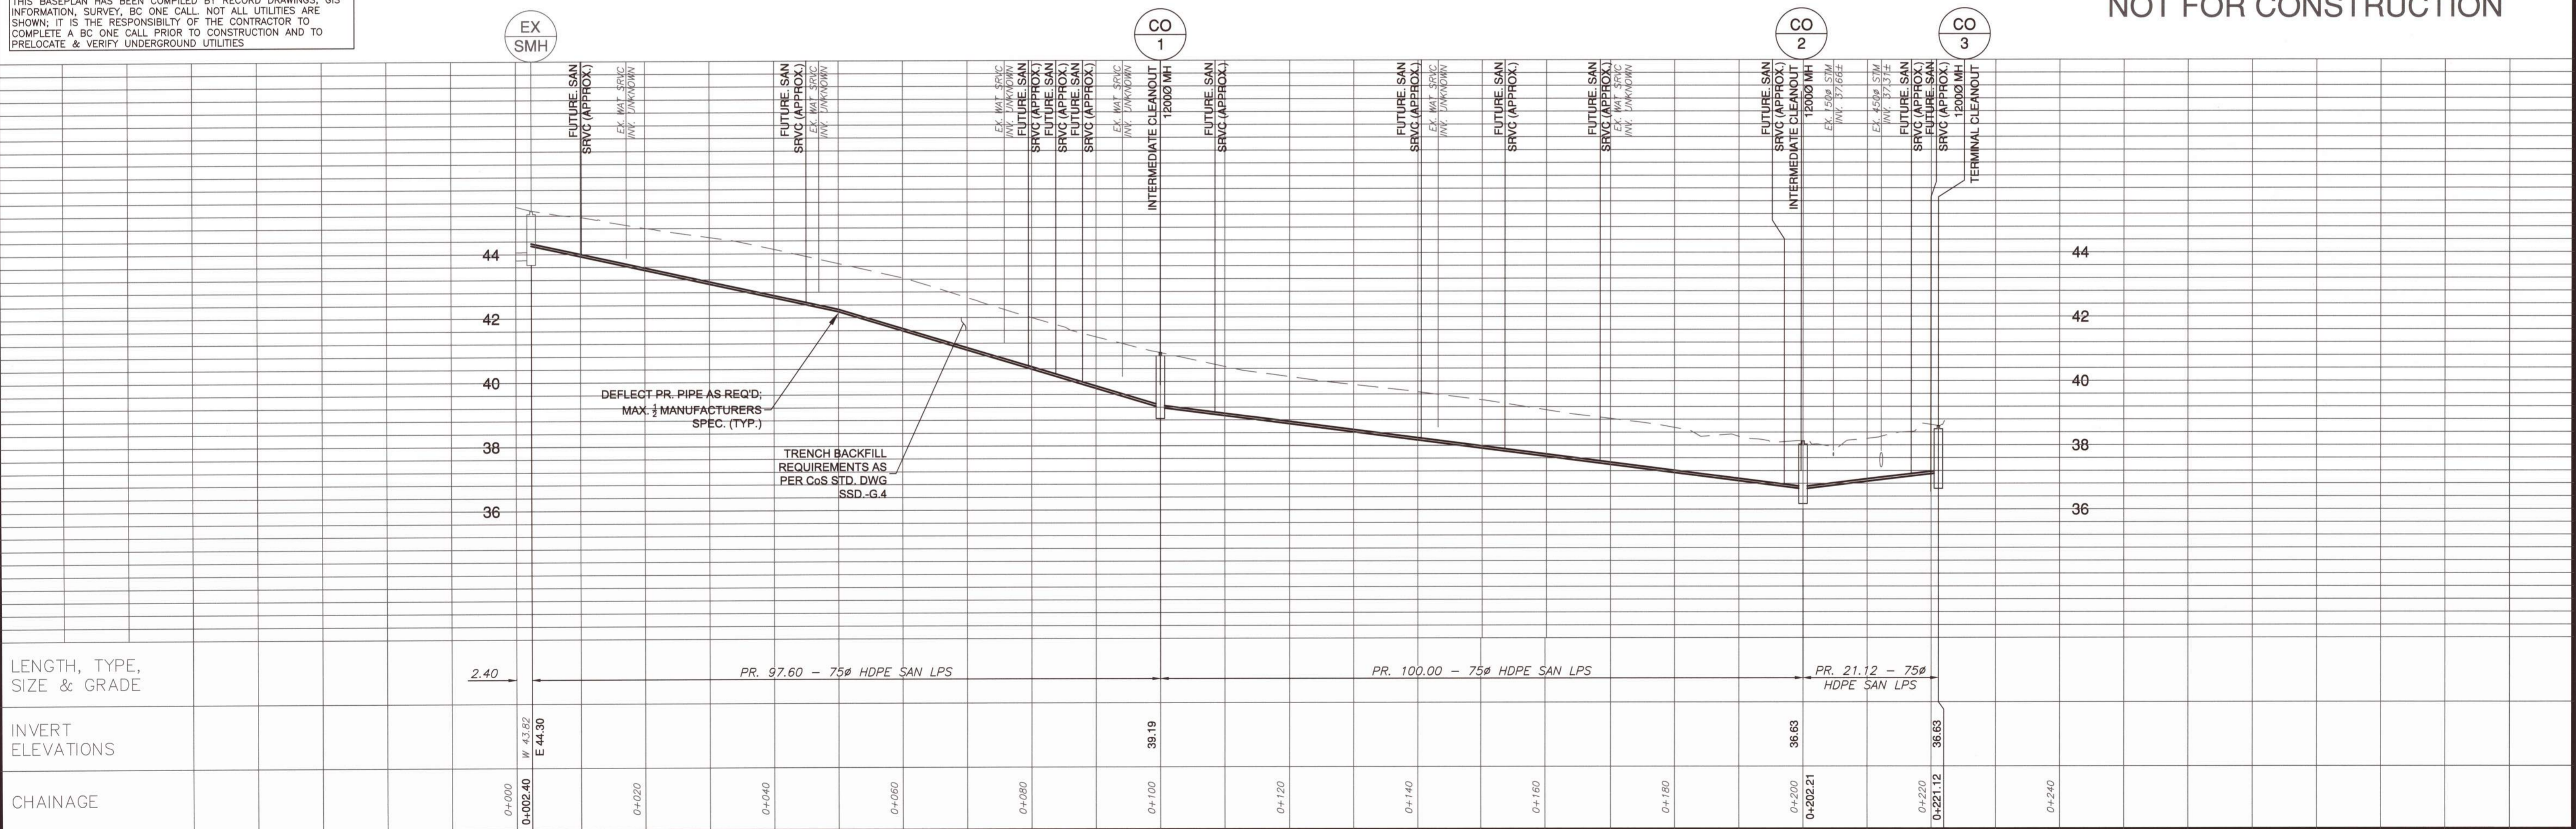

LEGAL DESCRIPTION NAD83 CSRS, CVD28 GVRD		CONSULTANT		CLIENT CITY OF SURREY 13450 - 104 AVE. SURREY, B.C., CANADA V3T 1V8		SEAL OCT 14 2022 PROFESSIONAL ENGINEER A. JAIN #50847 PERMIT TO PRACTICE 1003295		SCALE: 1:500		DATE (YYYY.MM.DD) 20220314		SURREY PROJECT NUMBER S-19487	
SURVEY BENCHMARK MON-92H0871 N 508006.143 E 5444840.901 SCALE FACTOR: 0.9995932 ELEV. 96.102		PROFESSIONAL ENGINEER, IN GOOD STANDING IN AND FOR THE PROVINCE OF BRITISH COLUMBIA, HEREBY CERTIFY THAT THE WORKS AS HEREIN SET OUT ON THE ATTACHED DRAWINGS HAVE BEEN DESIGNED TO GOOD ENGINEERING STANDARDS AND IN ACCORDANCE WITH THE LATEST EDITION OF THE CITY OF SURREY DESIGN CRITERIA MANUAL, THE MMCD, AND THE CITY OF SURREY STANDARD CONSTRUCTION DOCUMENTS (GENERAL CONDITIONS, SUPPLEMENTARY SPECIFICATIONS AND SUPPLEMENTARY STANDARD DRAWINGS), ADOPTED BY THE CITY OF SURREY.		TITLE 54 AVENUE: 12710-12807 LOW PRESSURE SEWER PLAN AND PROFILE		DESIGNED RI		DWG. NO. S1		CITY FILE NUMBER		DRAWING TYPE CIVIL	
REV. DATE DESCRIPTION APP						DRAWN RI		REV. 2					
2022/10/06 ISSUED FOR TENDER AJ						REVIEWED DM							
2022/07/22 ISSUED FOR REVIEW JC													